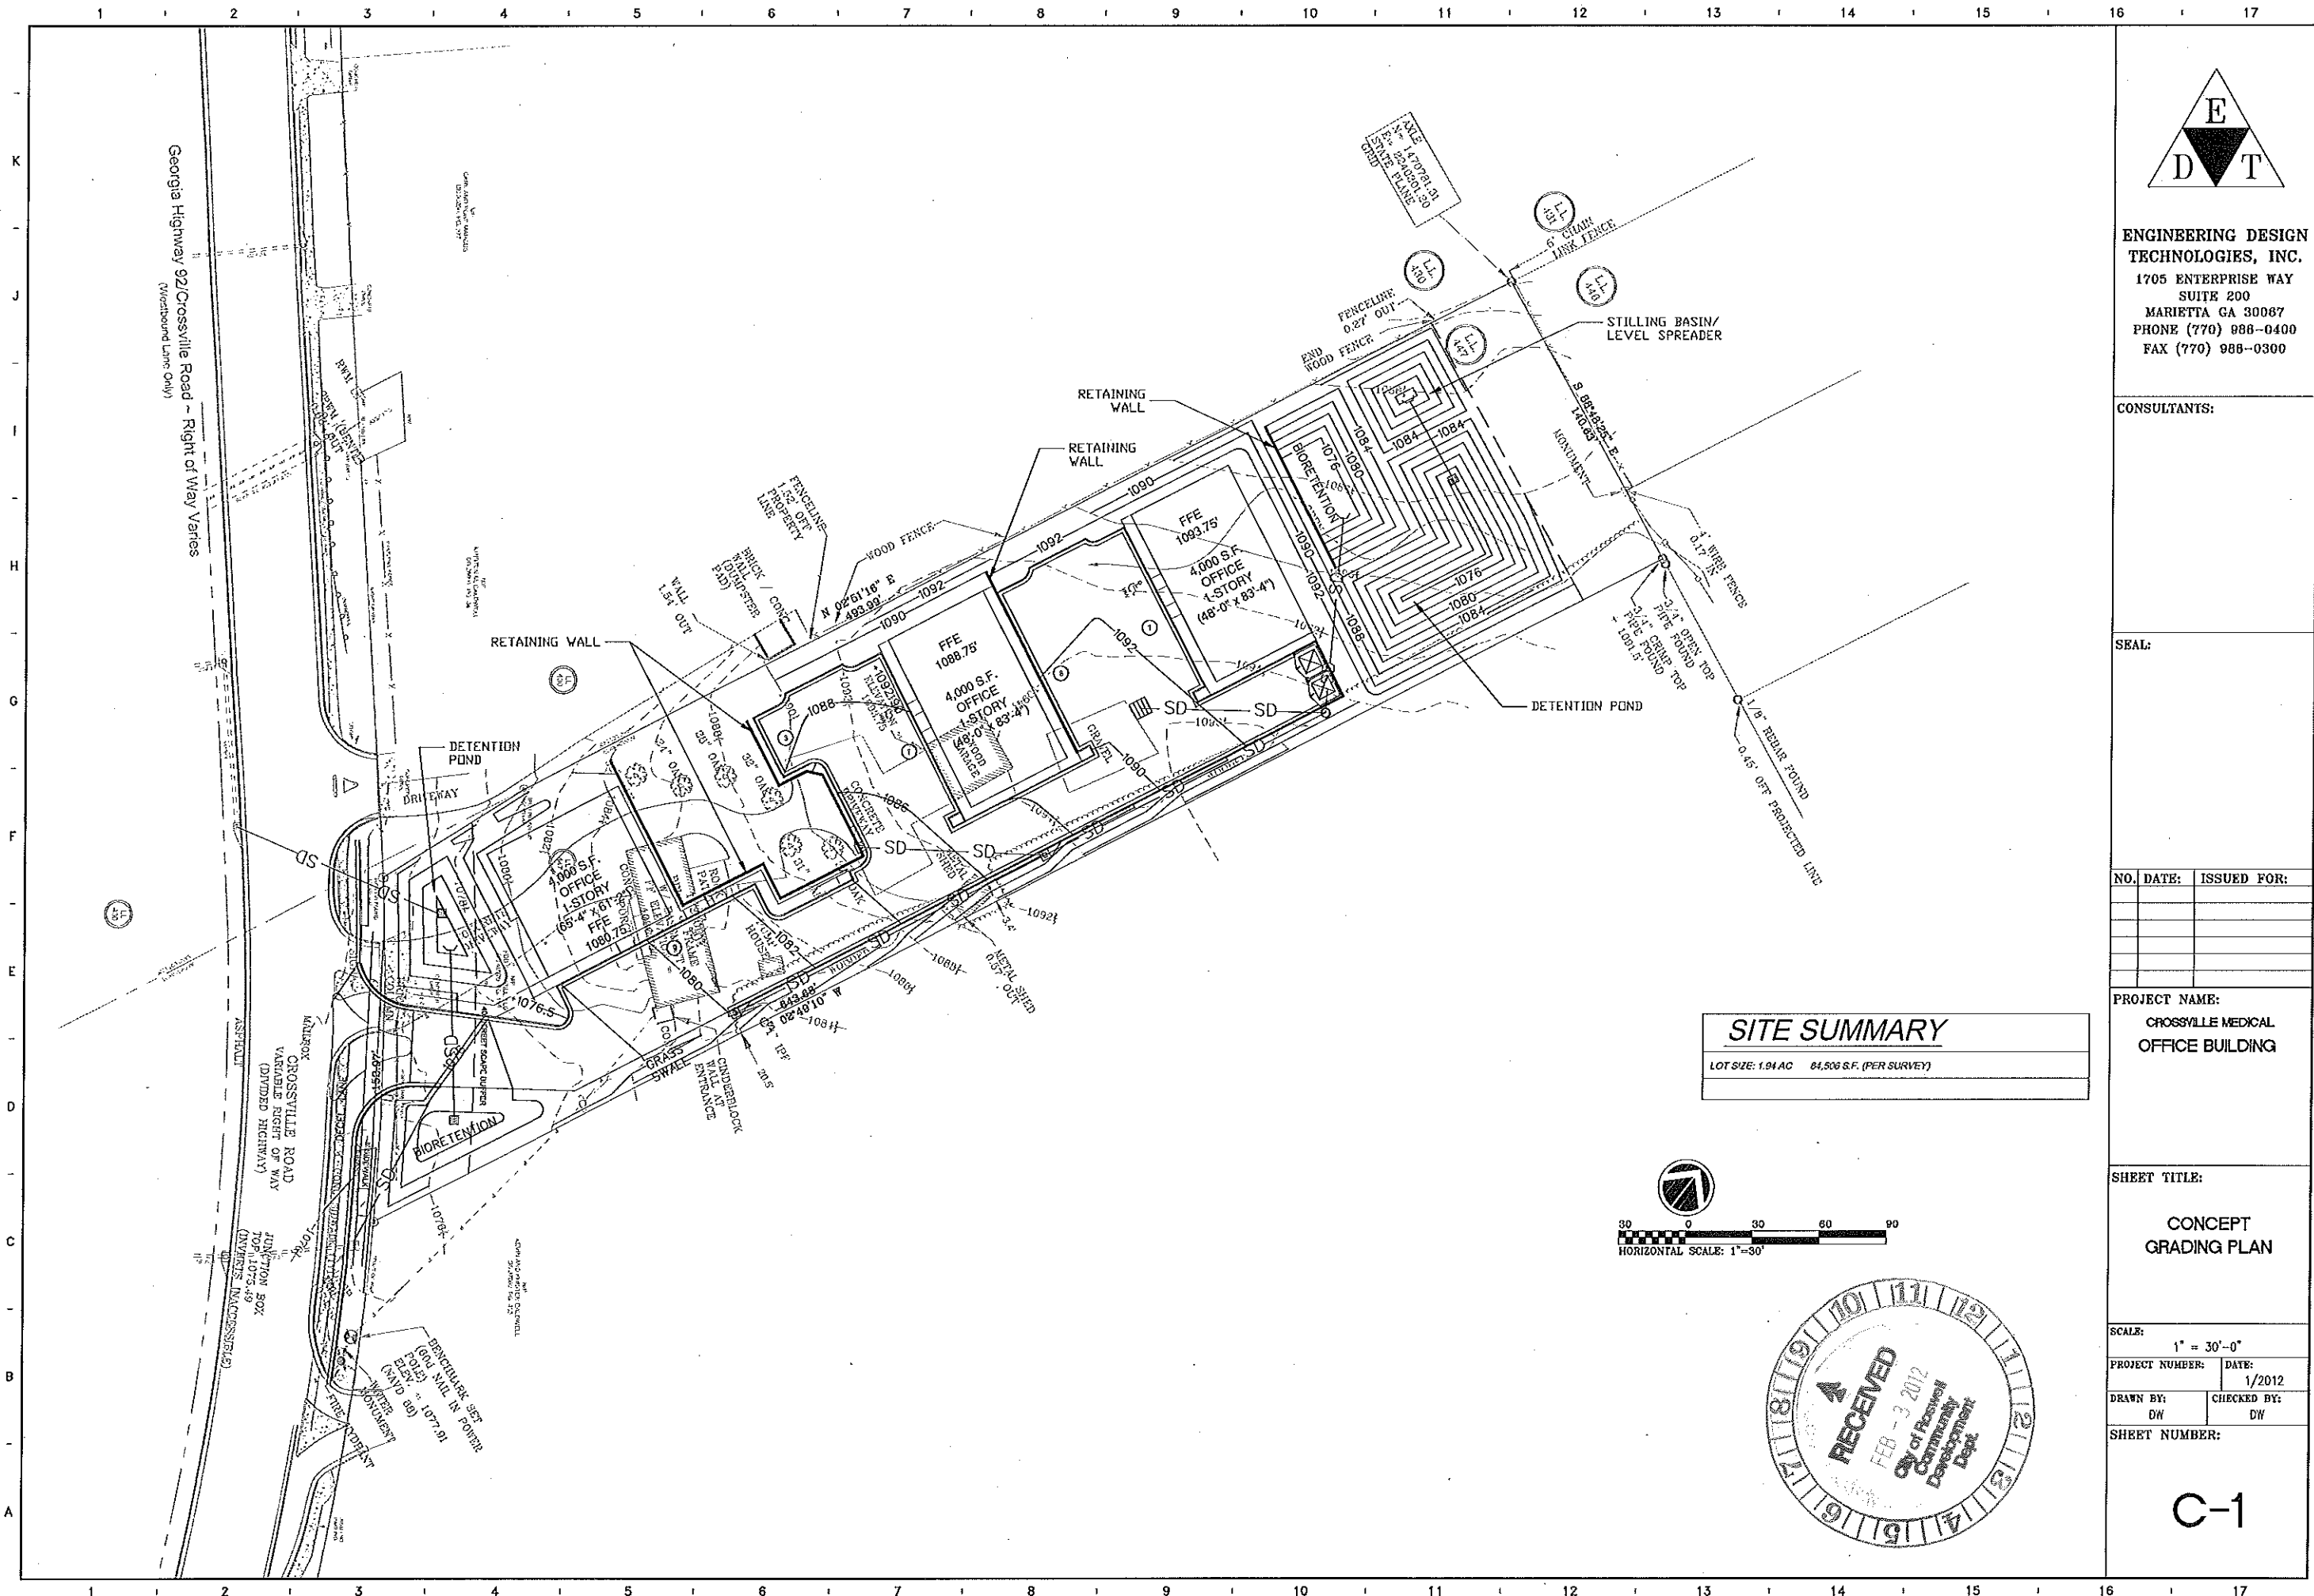


ENGINEERING DESIGN
TECHNOLOGIES, INC.
1705 ENTERPRISE WAY
SUITE 200
MARIETTA GA 30067
PHONE (770) 988-0400
FAX (770) 988-0300

CONSULTANTS:

SEAL:

NO.	DATE:	ISSUED FOR:

PROJECT NAME:
CROSSVILLE MEDICAL
OFFICE BUILDING

SHEET TITLE:
CONCEPT
GRADING PLAN

SCALE:
1" = 30'-0"
PROJECT NUMBER: DATE: 1/2012
DRAWN BY: DW CHECKED BY: DW
SHEET NUMBER:

C-1