




Preliminary DWG.
 In Progress
 9/28/12
 SSOE, Inc.

10/15/2012

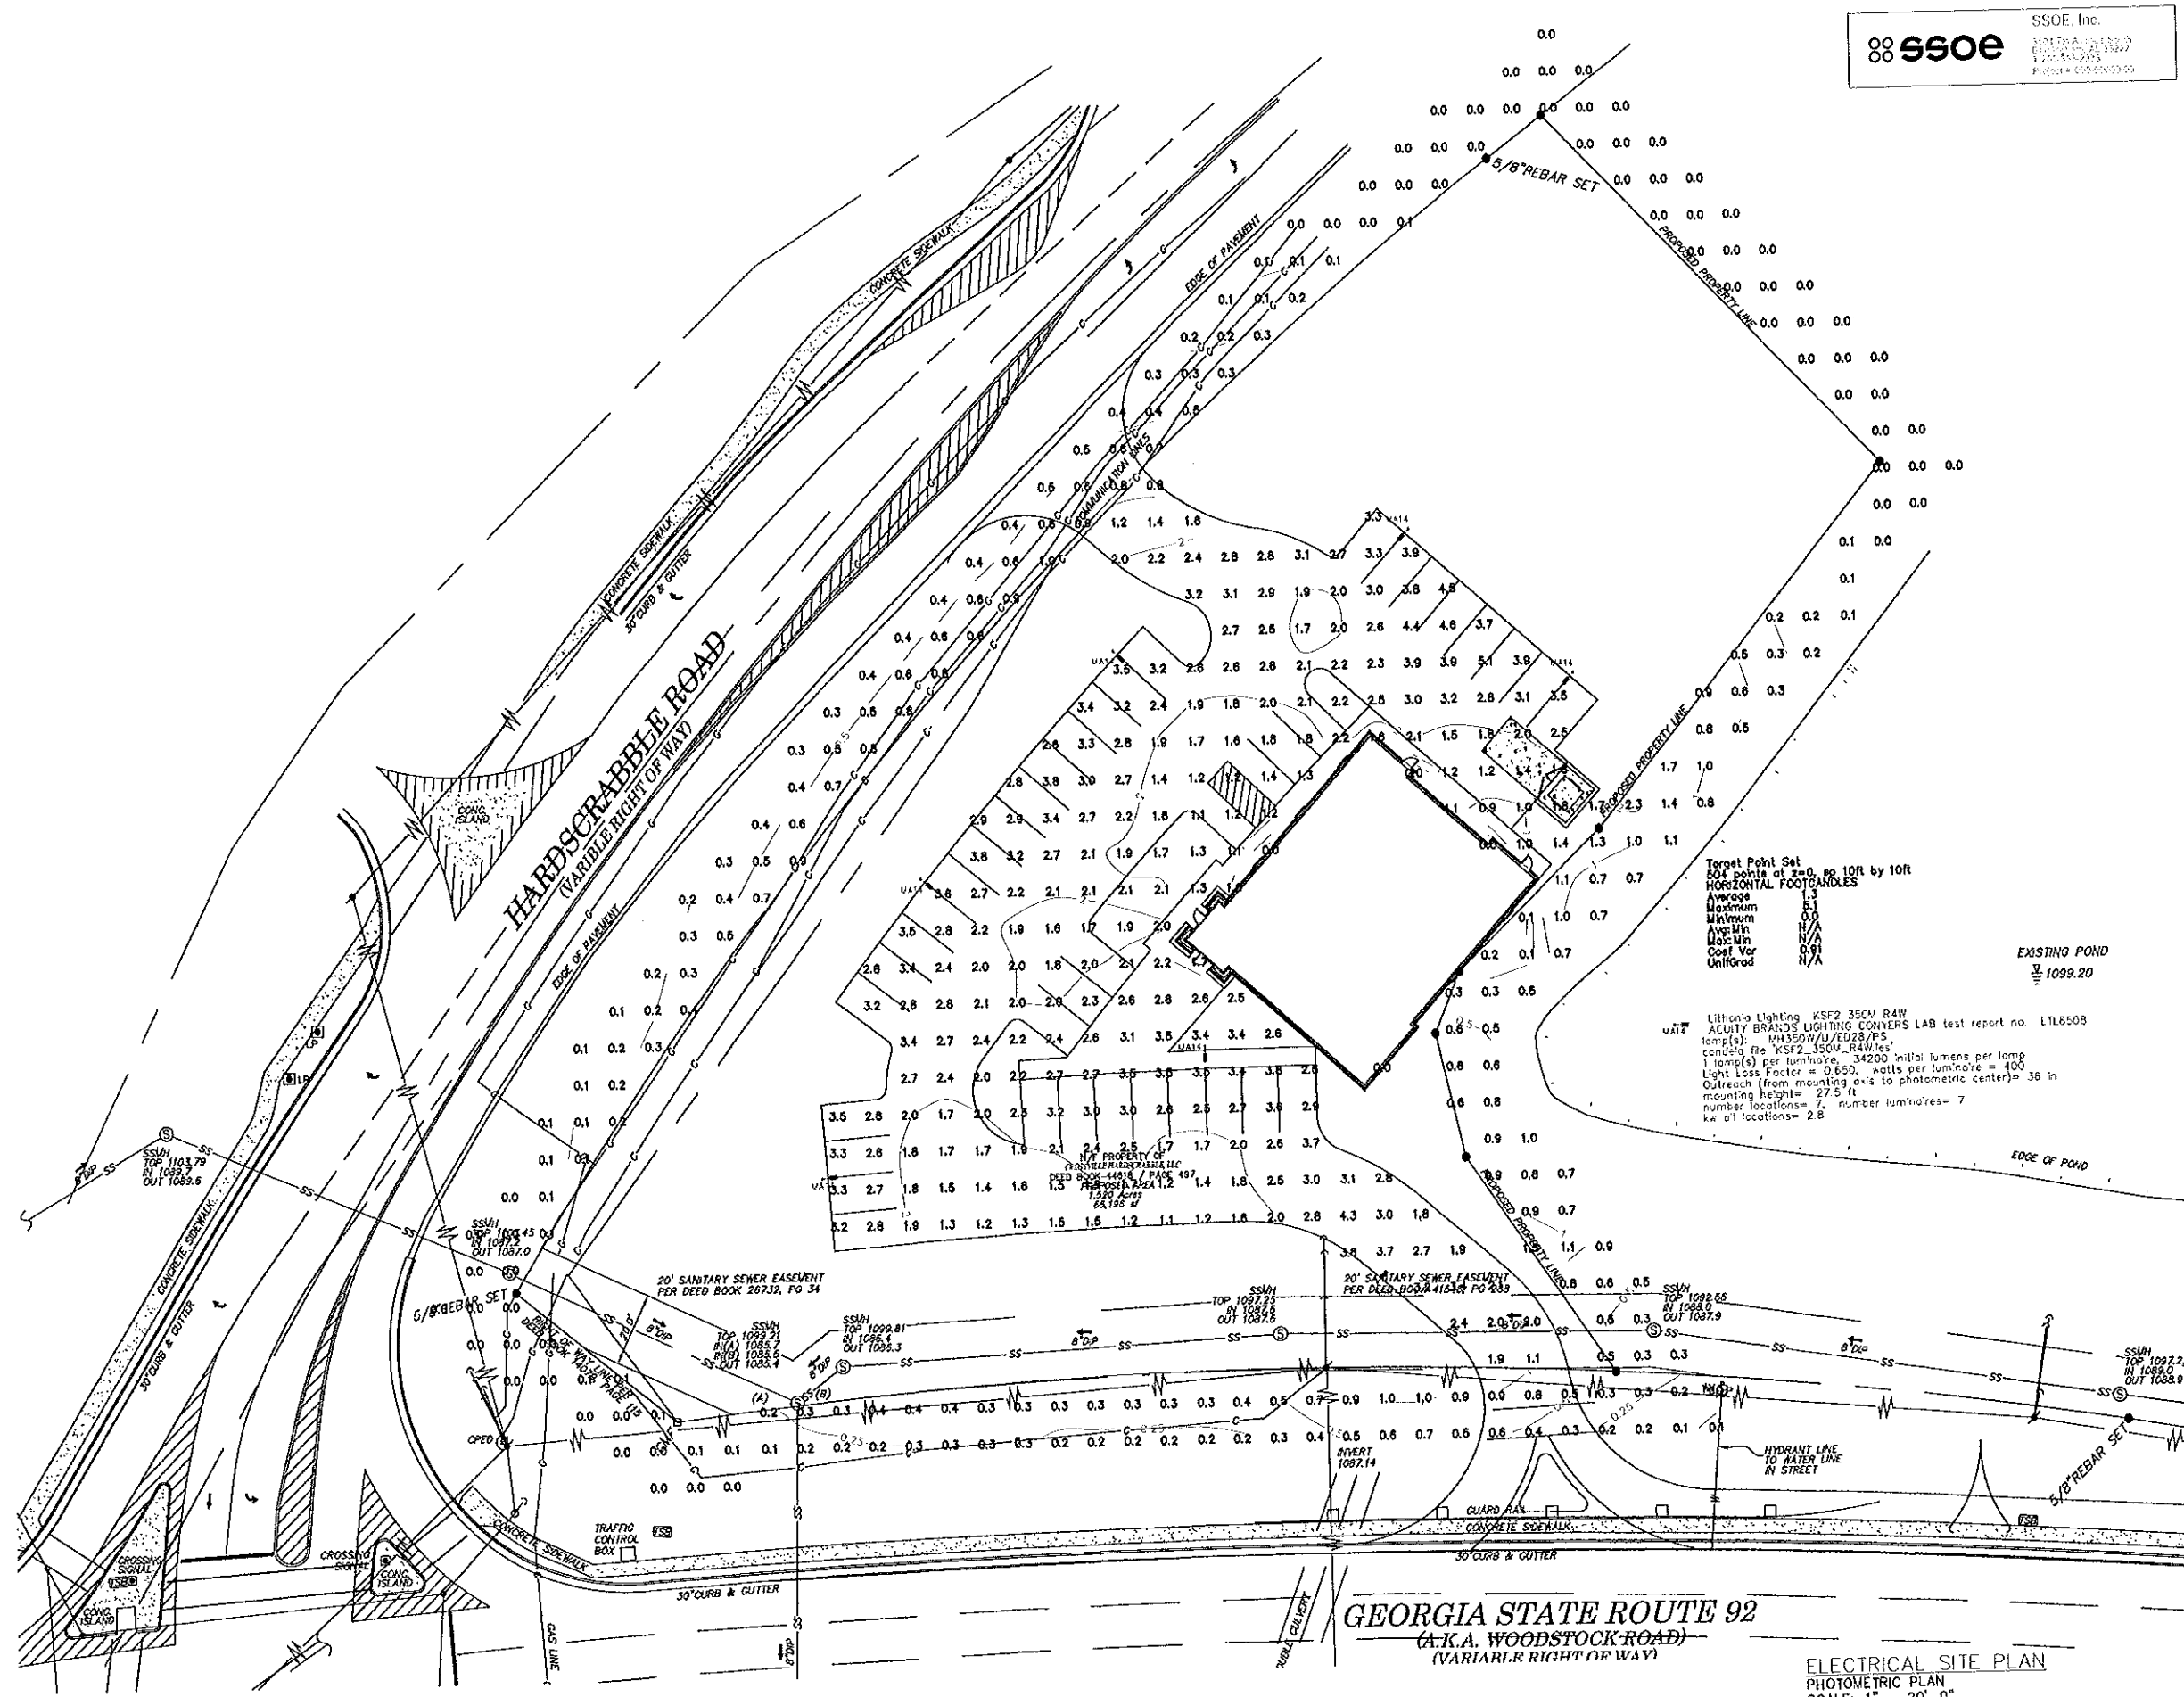

GEORGIA STATE ROUTE 92
 (A.K.A. WOODSTOCK ROAD)
 (VARIABLE RIGHT OF WAY)

ELECTRICAL SITE PLAN
 PHOTOMETRIC PLAN
 SCALE: 1" = 20'-0"