

RAVEN
SMALL RCS
SERIES

 
Cat. #		Approx.
JOB	TYPE	

ATTACHMENTS

- Provides a superior lighting solution for a wide array of creative lighting applications.

- **Life expectancy**

- [illegible]



	A	B	C	DA	Weight
MS	0.5"	1.25"	1.5"	1.75"	45 lbs
	25 mm	63 mm	381 mm	44 mm	19.1 kg

MS, DA average from 20 individual readings per.

ORDERING INFORMATION

OPENING EXAMPLE

RC3 • A4 • P43 • H3 • F • Q • D8 • L

Index • Search • Webpage Search • List • Link • Wrap • Color • Options

[illegible]

1 Being aware of what you are saying
2 Being able to understand
3 Being able to express your feelings
4 Being able to listen to others

Poles



Squidling's complete line of poles offers simple solutions for all your lighting needs. From 1' to 18' in height, pole applications include general floodlighting, sports lighting, tower & derrick, commercial site lighting, and so on. Mounting configurations include tower top, side mount, pole mount, or open top model to suit a luminaire style.


Compatible with existing standards,
both for aluminum and steel coils.

ORDERING INFORMATION

[illegible]

- [illegible]

 This rule book is for reference use only. The appropriate rule table should be used when citing and defining rules.

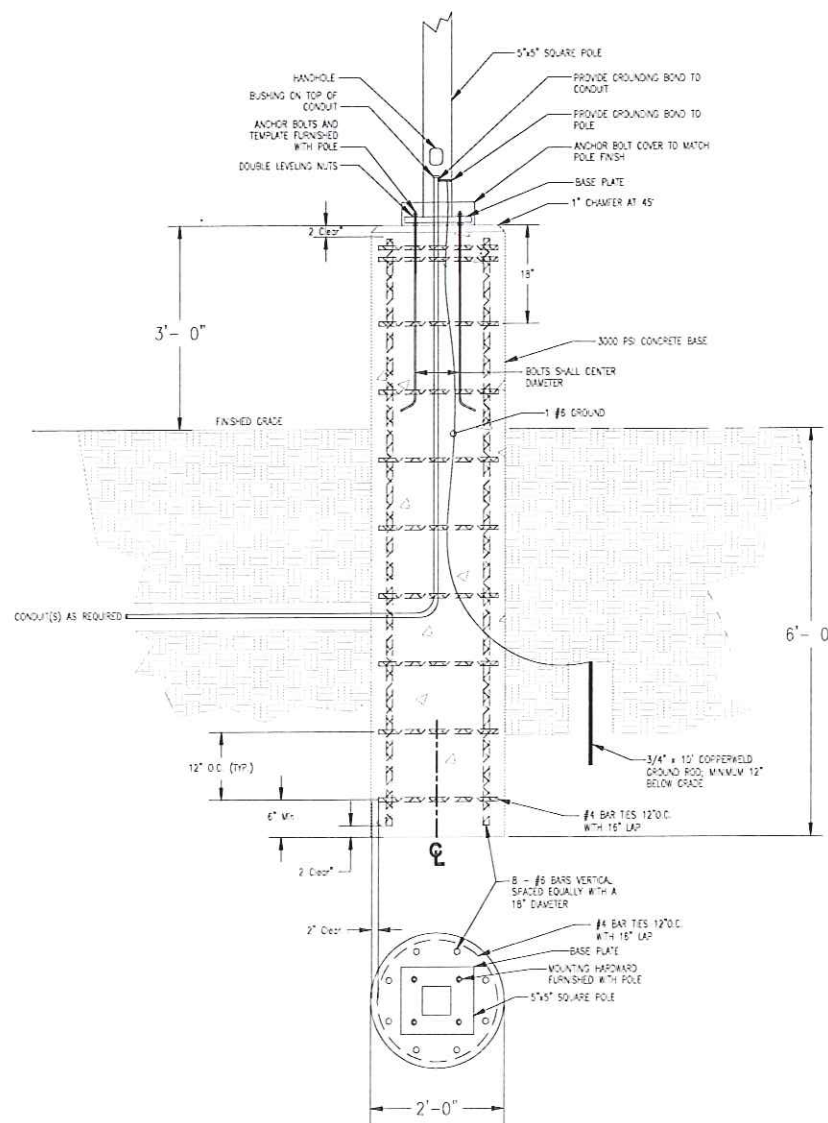

1 LIGHTING POLE BASE DETAIL
E000 N.T.S.

SITE LIGHTING FIXTURE SCHEDULE	
SYMBOL	TYPE DESCRIPTION
	SA SINGLE LUMINAIRE OUTDOOR POLE LIGHT. EXTRUDED ALUMINUM RECTANGULAR ("SHOEBOLT" TYPE) HOUSING, TWO CARBIDES AND TALL TEMPERED GLASS LENS. WIRING IS AS CRITERIA FOR FULL OUTLET LIGHT DISTRIBUTION, WITH 0.8X DARK SKY. FREQUENCY 50% OF ADDITIONAL HORIZONTALLY ORIENTED HIGH PRESSURE SODIUM LAMP. HYDROFORMED REFLECTOR WITH 65 TIES IN OPTICS MOUNT ON 30" TALL SQUARE STAGNA STEEL POST WITH 4X8W TO SIDE BOWLED APOA AND 3" CONCRETE BASE (REFER TO DETAIL 1/2000 THIS SHEET). SOUTH AREA 1 (3) EATING, DARK BIMATE FORGER CONT FENSA LU, WET LIGHTING LIMITED GLAD-7.0A BALLAST. FIXTURES TO MATCH EXISTING POLE LIGHTS RECENTLY INSTALLED IN NORTH PARKING LOT EXCEPT USE HIGH PRESSURE SODIUM LAMPS AS REQUIRED CITY OF ROSHARL. LAMPS: (1) GENERAL, ELECTRIC LUCALUX LU420/ OR EQUAL 420W HIGH PRESSURE SODIUM (ED-18) MANUFACTURER: HUBBELL SPAULDING LUMINAIRE: RAGEN SVAL, SERIES RGS-AM-542-H3-F-0-28 POLE: BSS-35-5-1-1-AM-08 WITH BASE COVER
	SB SAME AS TYPE SA EXCEPT PROVIDE 20 POLE (SSS-20-5-1-AM-08)
	S2 SAME AS TYPE SB EXCEPT PROVIDE TWO LUMINAIRES ORIENTED AT 180° ON INDIVIDUAL POLE (20) (CA MOUNTING TYPE OPTION FOR POLE)

Revised: 05.22.200 DHE SUBMITTAL

Scale: 1" = 100'
Date: 07/10/10
Drawn by: JME
Checked by: JME

NORTH FULTON MEDICAL OFFICE BUILDING
NORTH FULTON REGIONAL HOSPITAL
HEMBREE ROAD & HIGHWAY 9
CITY OF ROSWELL, FULTON COUNTY, GEORGIA
NEW M.O.B. PARKING LOT SITE LIGHTING PLAN - PHOTOMETRIC CALCULATIONS


Stamp By:

Drawing Number:

E001

Duke Party Job Number:
NOR FUA-000

A/E Job Number:
10334

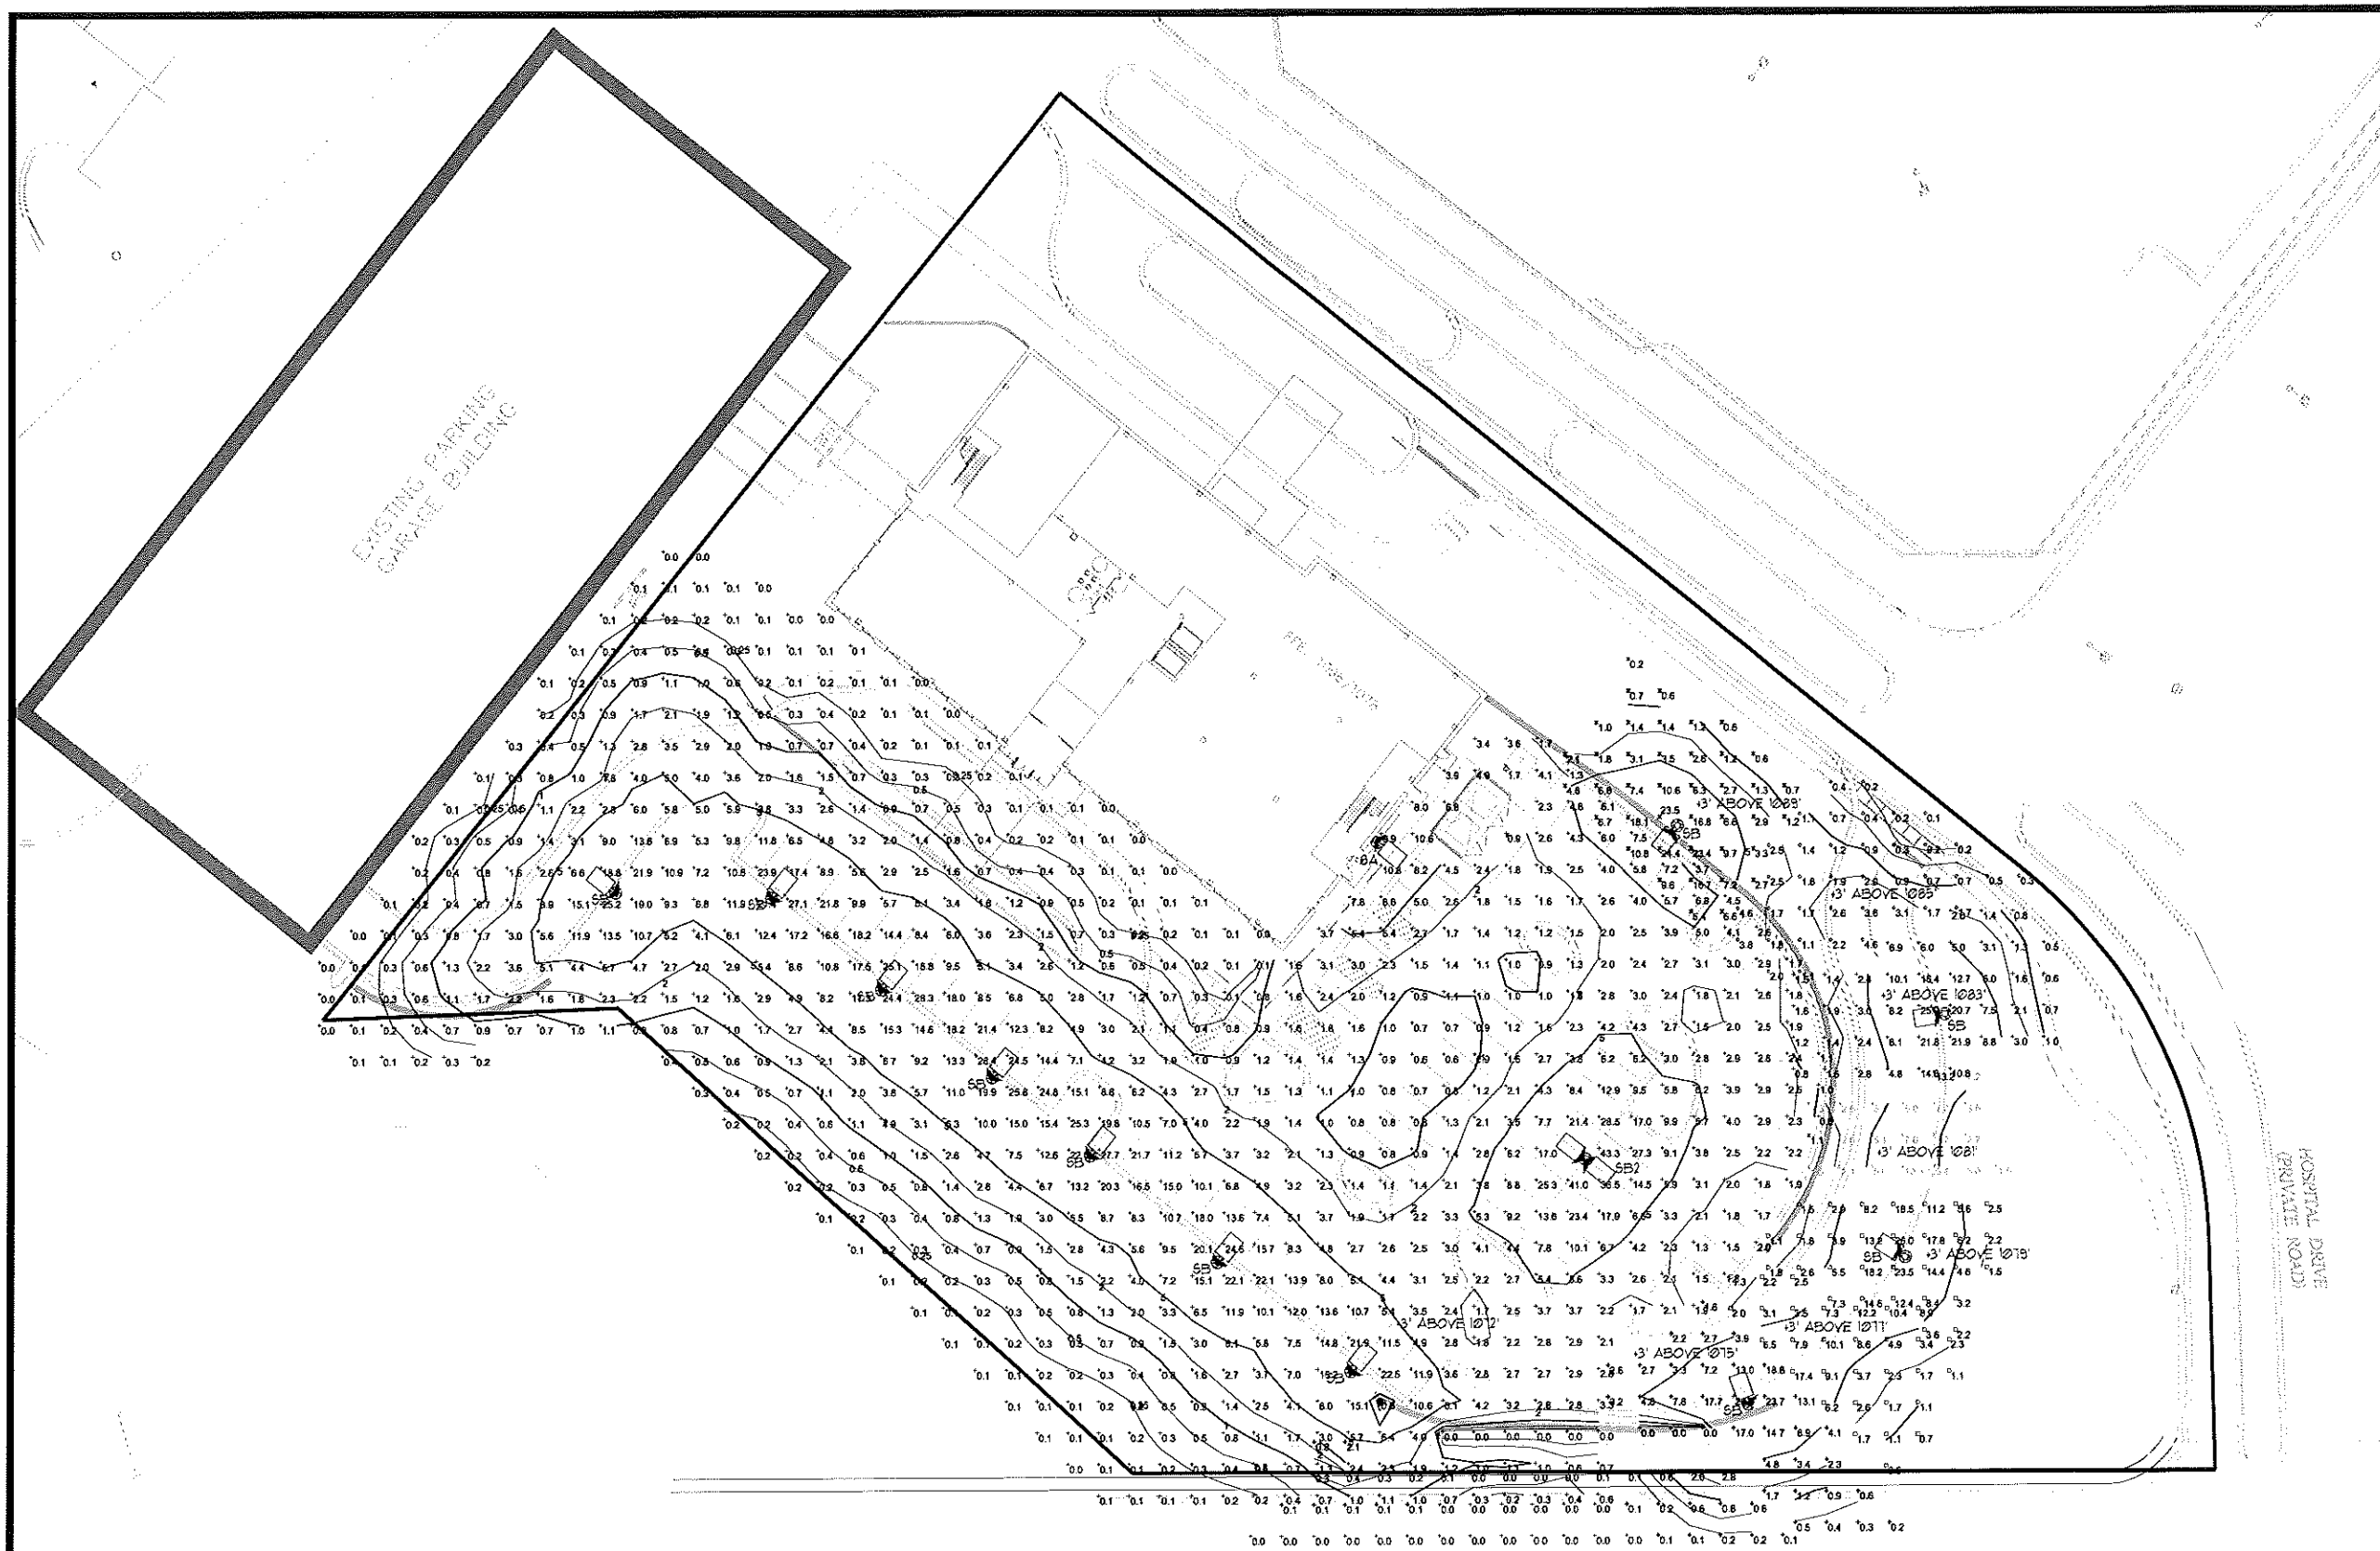

GENERAL NOTES:
1. PHOTOMETRIC VALUES SHOWN INDICATE ILLUMINANCE IN FOOTCANDLES (FC).

OVERALL REVISED SITE LIGHTING PLAN - PHOTOMETRIC CALCULATIONS