


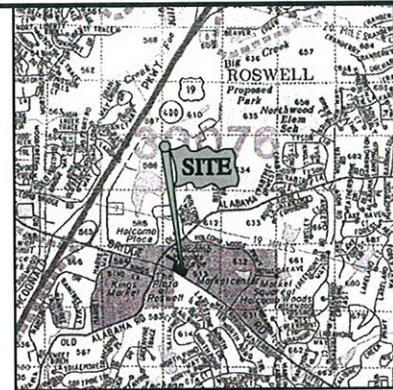

LOCATION MAP



Urban Engineers, Inc.

1904 MONROE DRIVE, N.E., SUITE 100
ATLANTA, GEORGIA 30324

PHONE: (404) 873-5874 / FAX: (404) 873-5877

REVISIONS


DATE	DESCRIPTION
10-13-09	1 ADDED BIOTRET. FACILITY

GRADING AND DRAINAGE PLAN

PROJECT NO.	20908-1
LAND LOT (S)	613
DISTRICT	1st, 2nd SECT.
COUNTY	FULTON
SCALE	1" = 20'
DATE	09/08/09

DRAWING NO.:

C-4

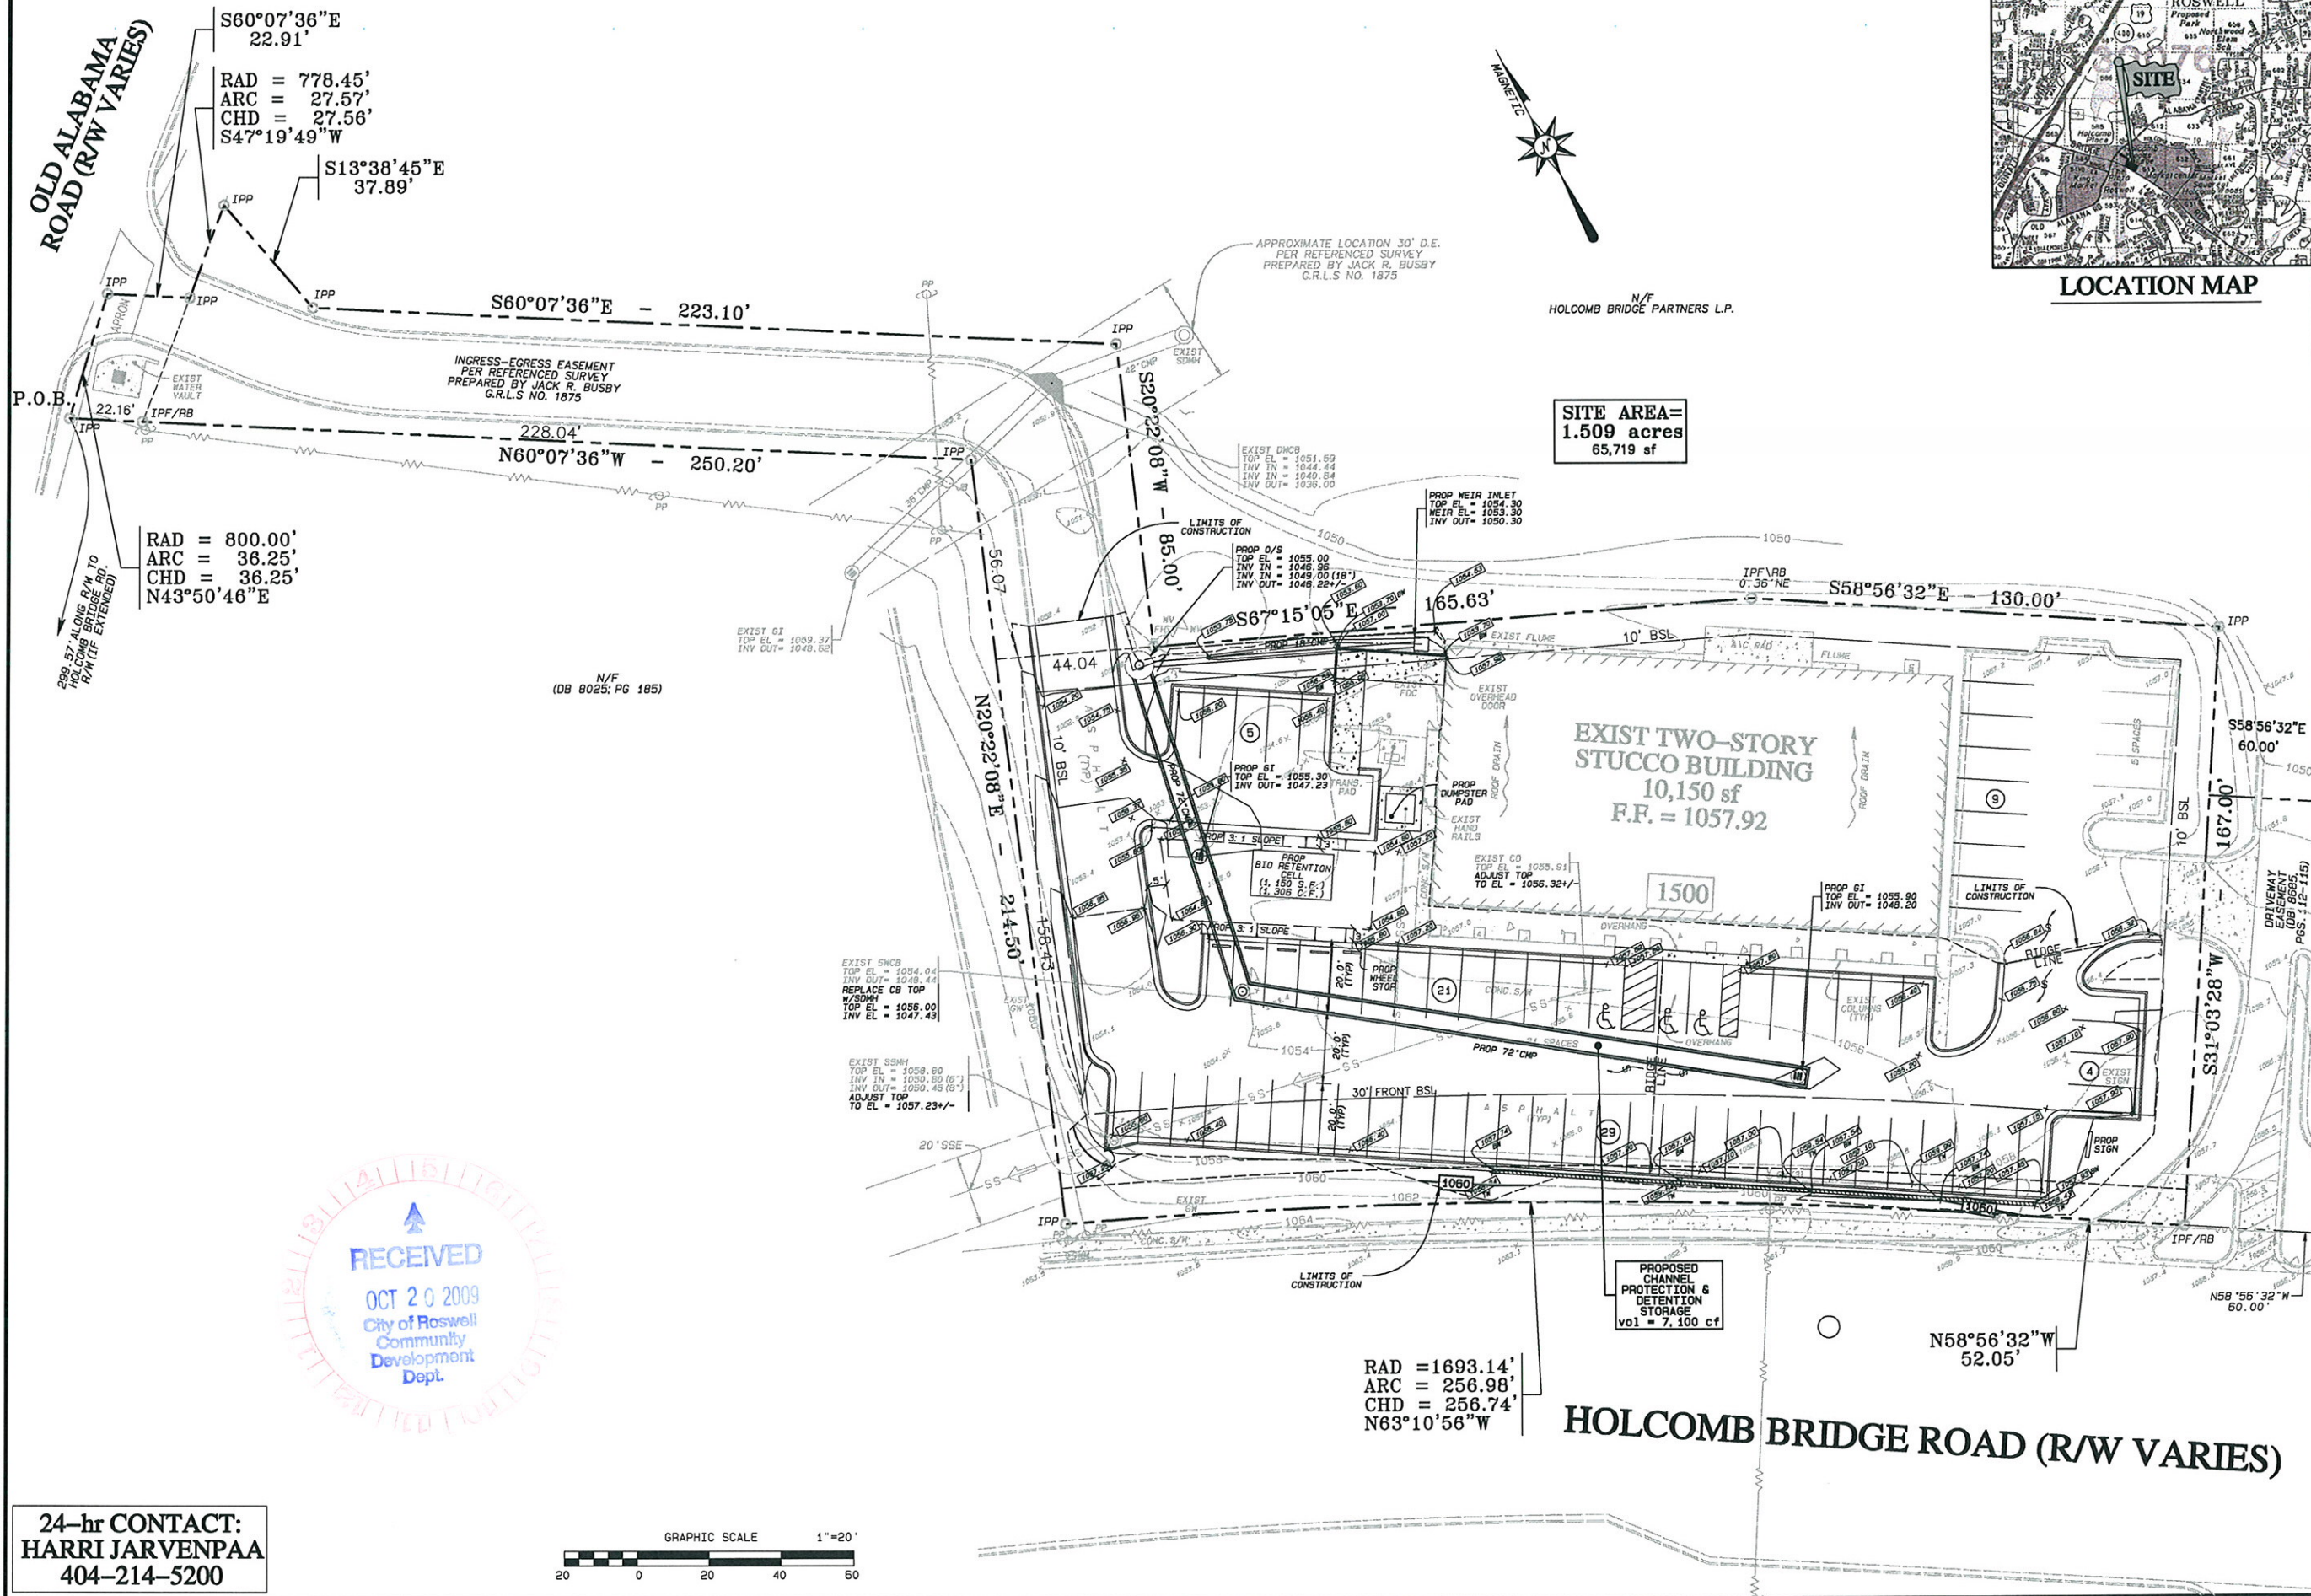

24-hr CONTACT:
HARRI JARVENPAA
404-214-5200

